





CC - Block C/F North Elevation

**GENERAL NOTES:**  
 This drawing is © 2023 PTE architects.  
 Use figured dimensions only.  
 All dimensions are in millimetres unless noted otherwise.  
 This drawing must be read in conjunction with all other relevant drawings and specifications from the Architect and other consultants.  
 If in doubt, ask.

**SETTING OUT NOTES:**  
 All setting out to be confirmed on site prior to construction - any discrepancy must be immediately reported to the Architect.  
 All partitions set out to studwork or structure.  
 For setting out and specification of M&E services refer to M&E Consultants documents.  
 For setting out and specification of structure refer to Structural Engineer's documents.

2 0 2 4 10 m  
 Metres 1:200

N

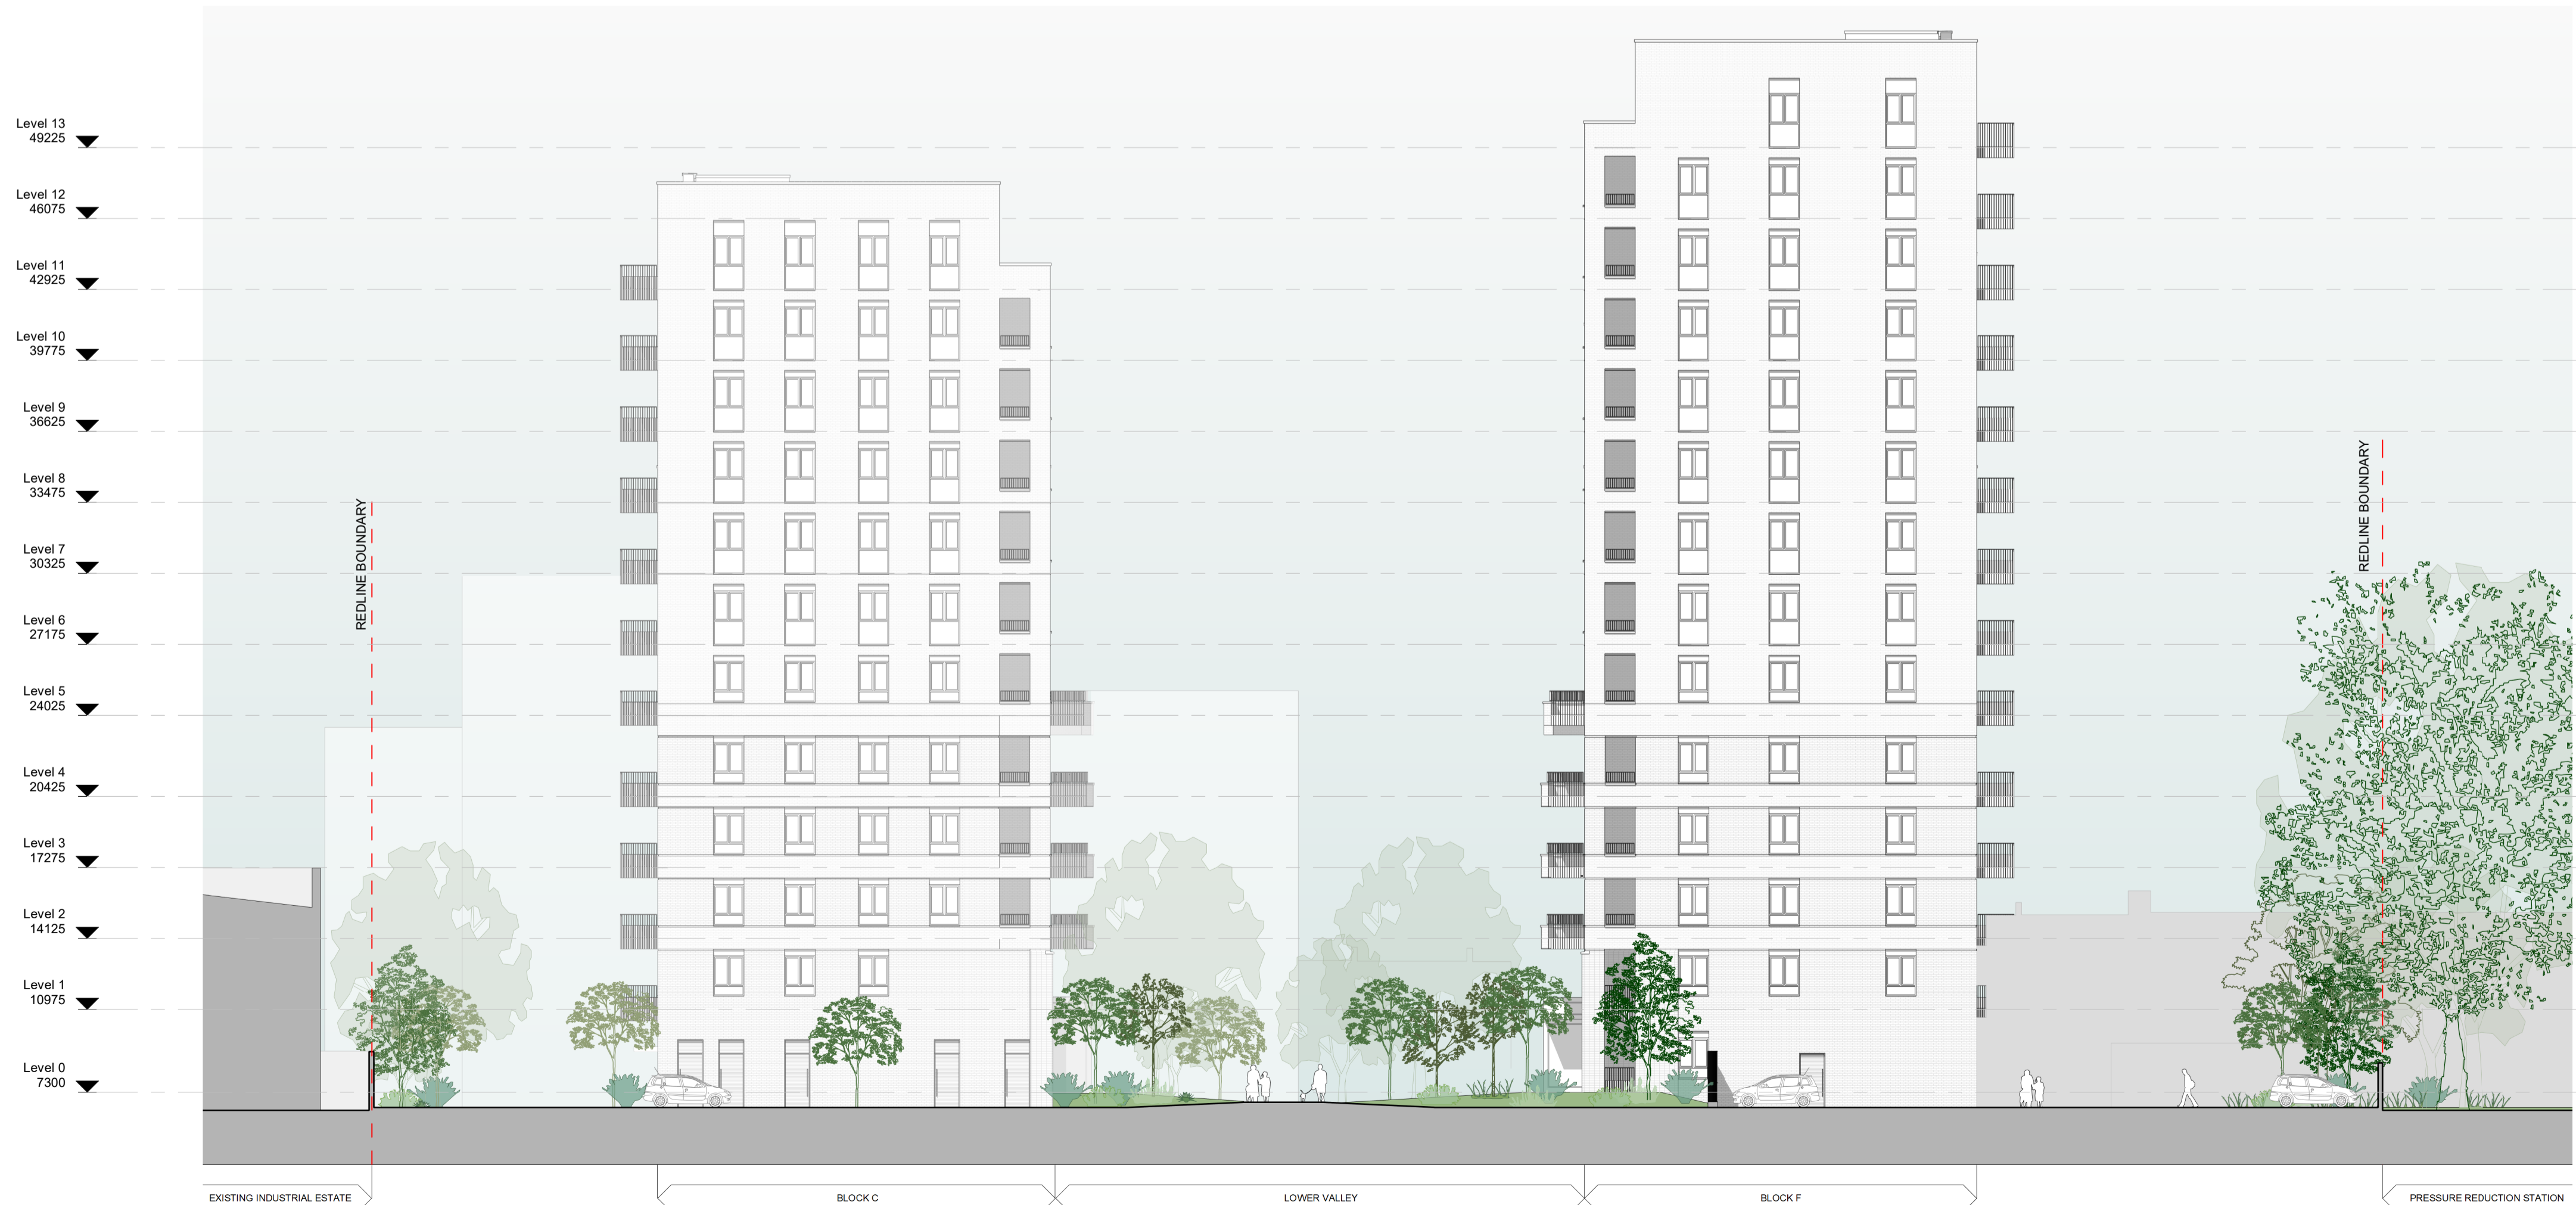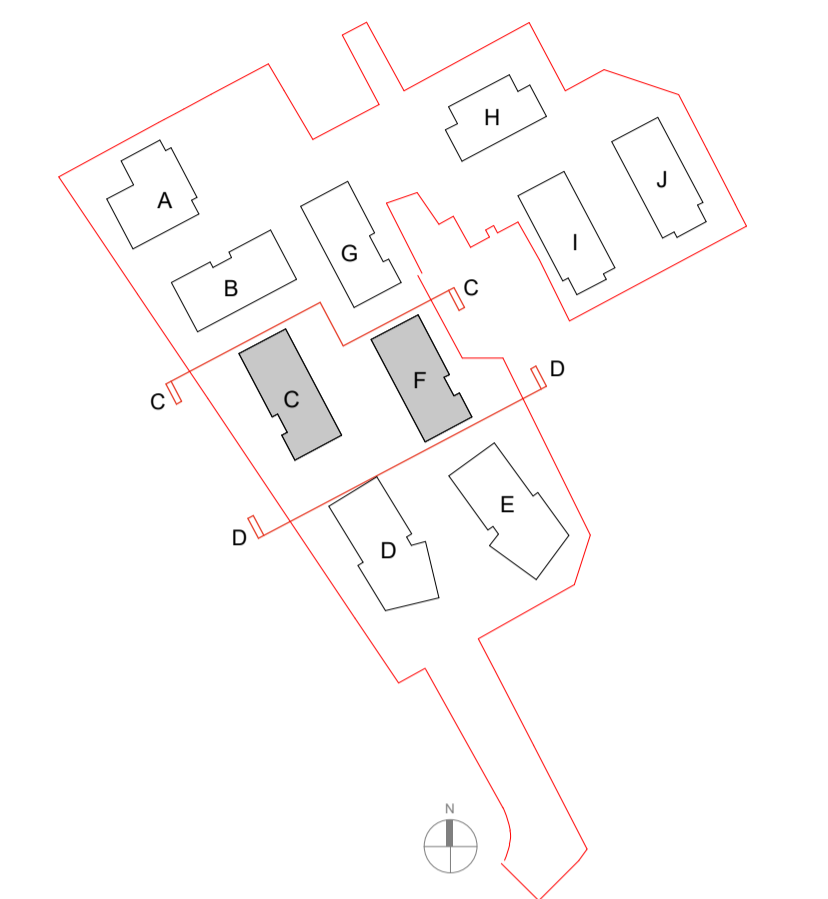

DD - Block C/F South Elevation

P2	02.02.24	Health Centre added	TR	NB
P1	31.10.23	First Issue (Planning Submission)	TR	MM
rev.	date	description	drawn	checked
drawing status				
<b>A3 - PLANNING</b>				
Diespiker Wharf 38 Graham Street London N1 8JX 020 7336 7777 forename.surname@ptea.co.uk @ptearchitects www.pollardthomasedwards.co.uk				
<b>Pollard Thomas Edwards</b>				
project	job number	drawn	scale	date created
Lea Bridge Gasworks	19-011	TR	1:200@A1	Oct23
drawing title	drawing number	submittal	revision	
<b>Elevations</b> Sheet 4 of 11	W406- POL02- ZZ-ZZ-DR-A-10-303	A3	P2	