
 
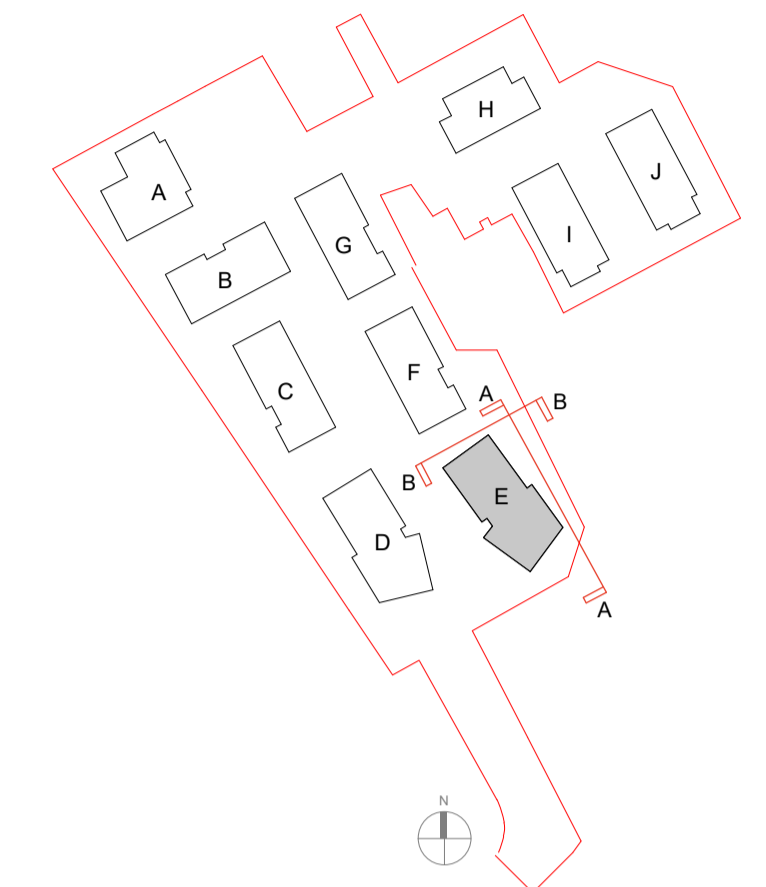


GENERAL NOTES:
 This drawing is © 2023 PTE architects.
 Use figured dimensions only.
 All dimensions are in millimetres unless noted otherwise.
 This drawing must be read in conjunction with all other relevant drawings and specifications from the Architect and other consultants.
 If in doubt, ask.

SETTING OUT NOTES:
 All setting out to be confirmed on site prior to construction - any discrepancy must be immediately reported to the Architect.
 All setting out to face of structure or to grid.
 All partitions set out to studwork or structure.
 For setting out and specification of M&E services refer to M&E Consultants documents.
 For setting out and specification of structure refer to Structural Engineer's documents.



AA - Block E East Elevation

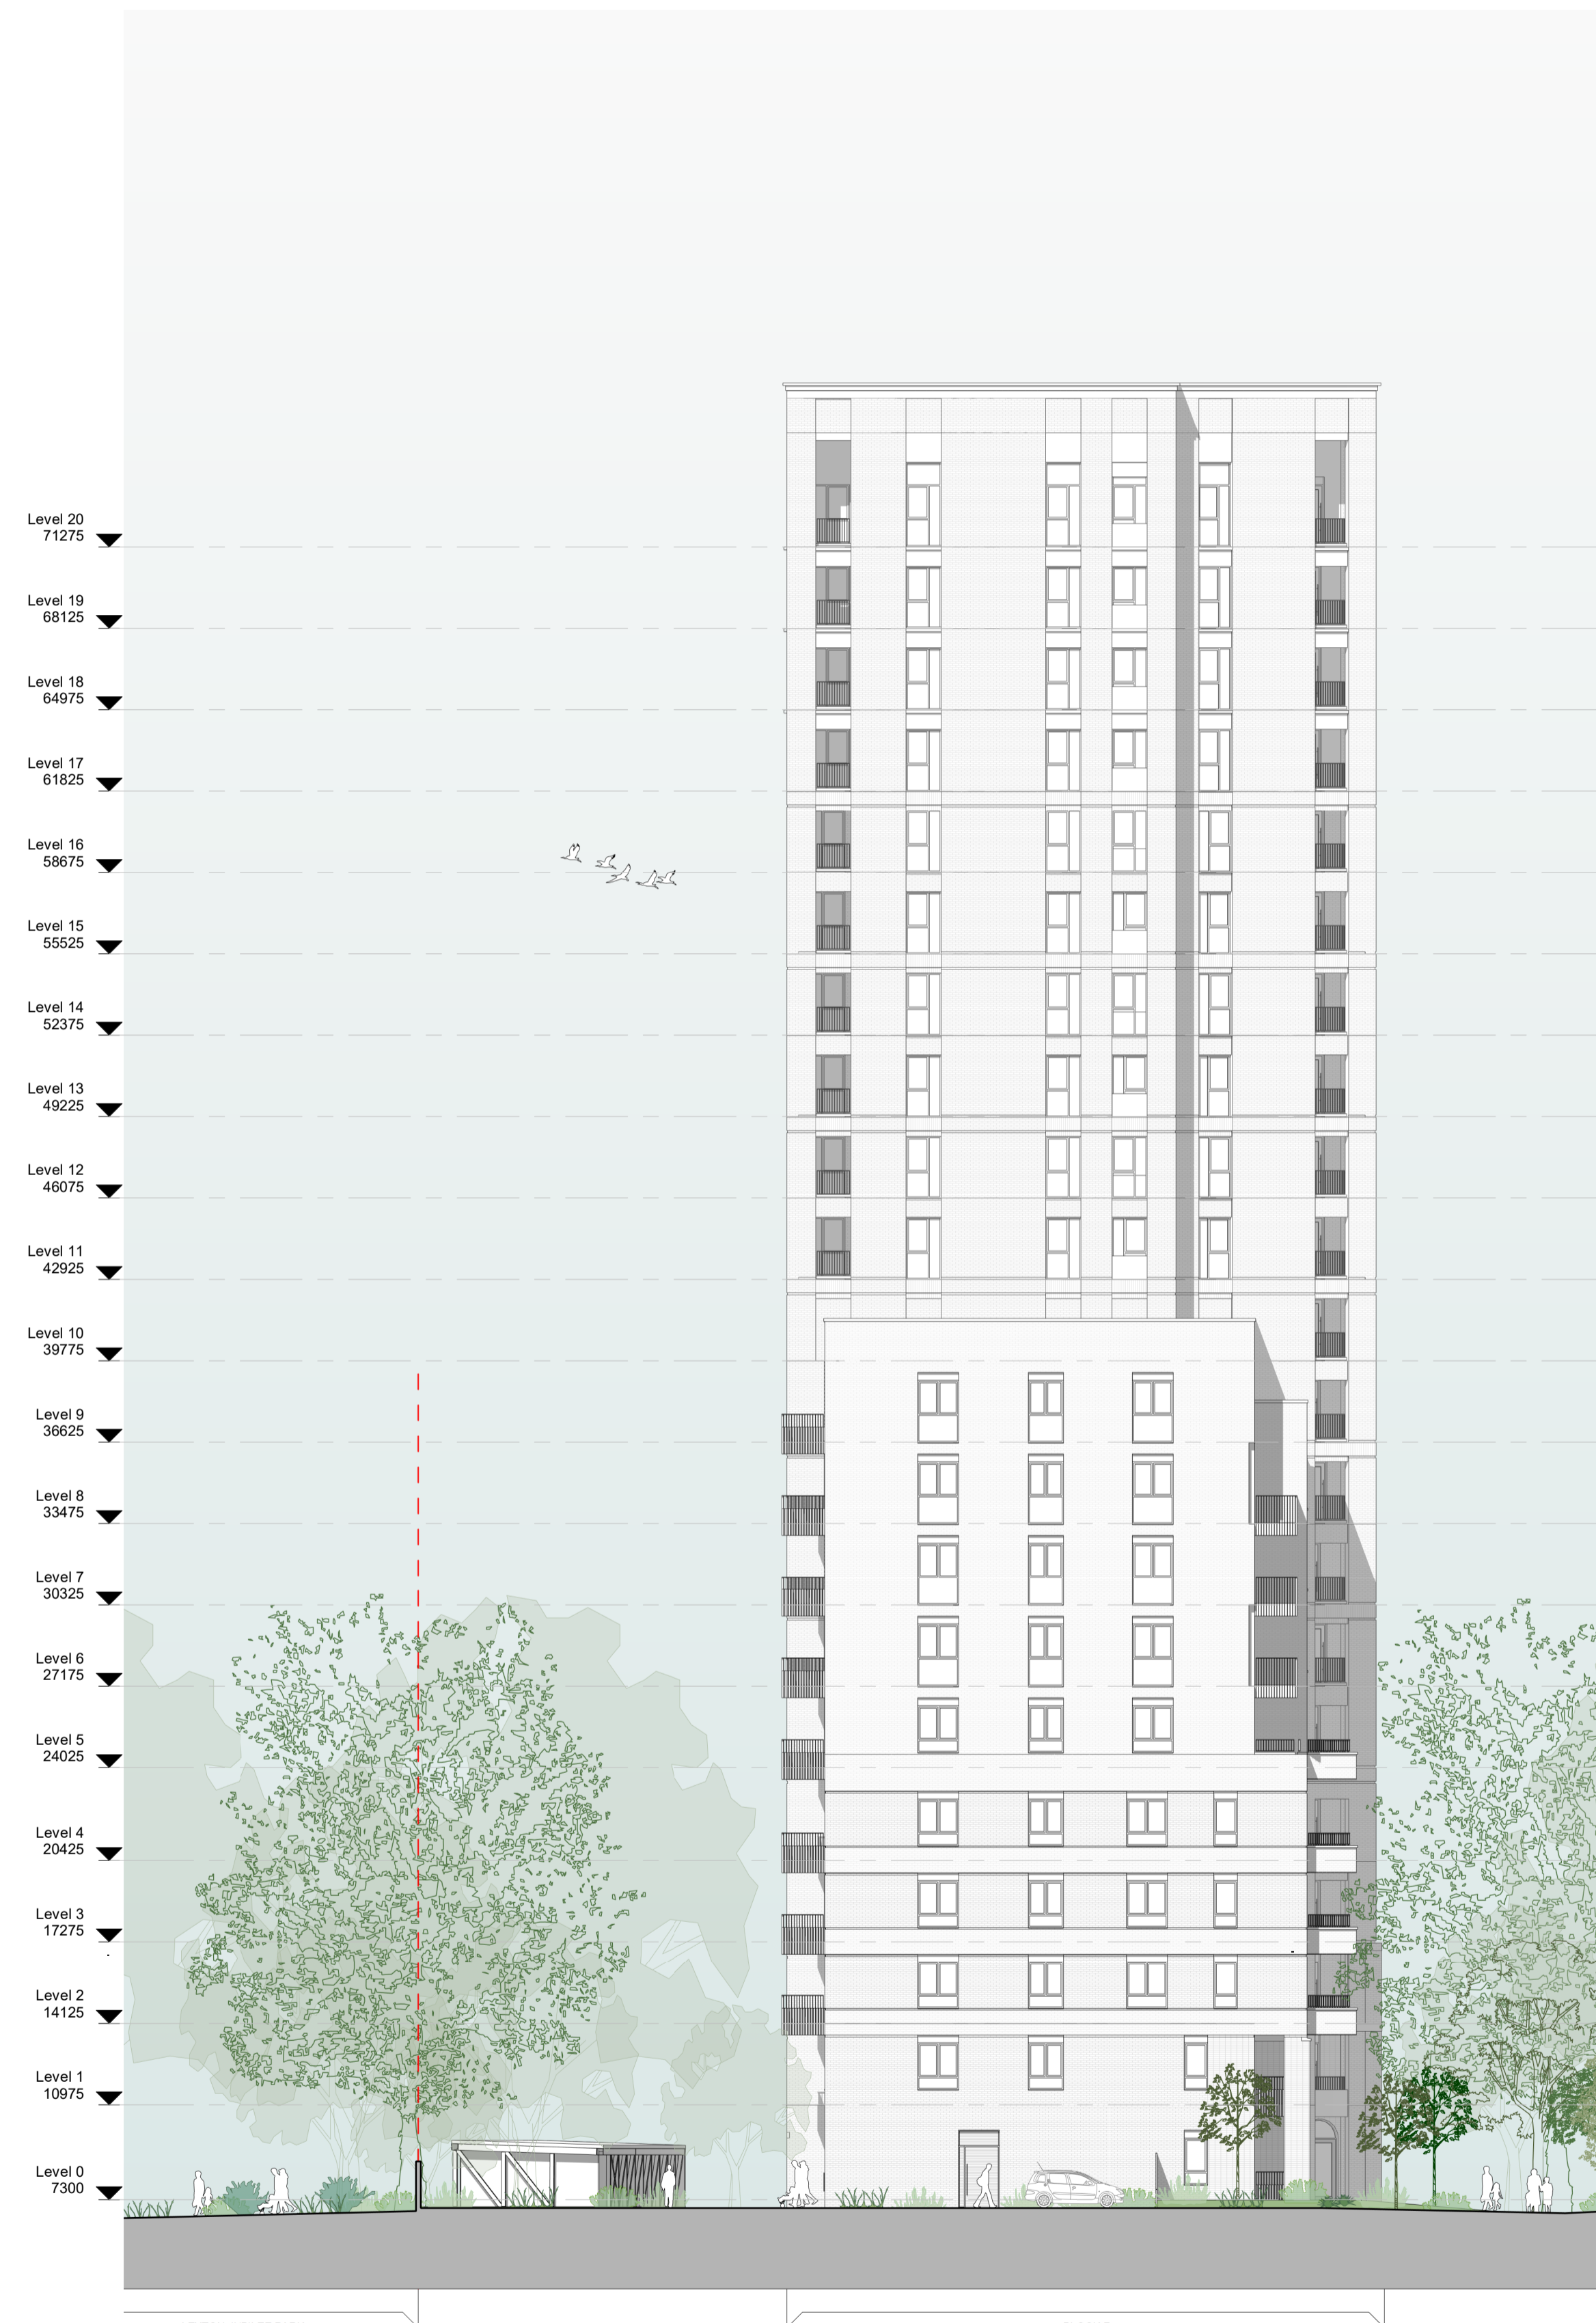

BB - Block E North Elevation

rev.	date	description	drawn	checked
P2	02.02.24	Health Centre added	TR	NB
P1	31.10.23	First Issue (Planning Submission)	TR	MM

A3 - PLANNING

Diespeker Wharf
 38 Graham Street
 London N1 8JX
 020 7336 7777
 forename.surname@ptea.co.uk
 @ptearchitects
 www.pollardthomasedwards.co.uk

**Pollard
 Thomas
 Edwards**

project	job number	drawn	scale	date created
Lea Bridge Gasworks	19-011	TR	1:200@A1	Oct23
drawing title	drawing number	subtitle	revision	
Elevations	W406-POL02-ZZ-ZZ-DR-A-10-307	A3	P2	