


- This drawing is prepared solely for design and planning submission purposes. It is not intended or suitable for either Building Regulations or Construction purposes and should not be used for such

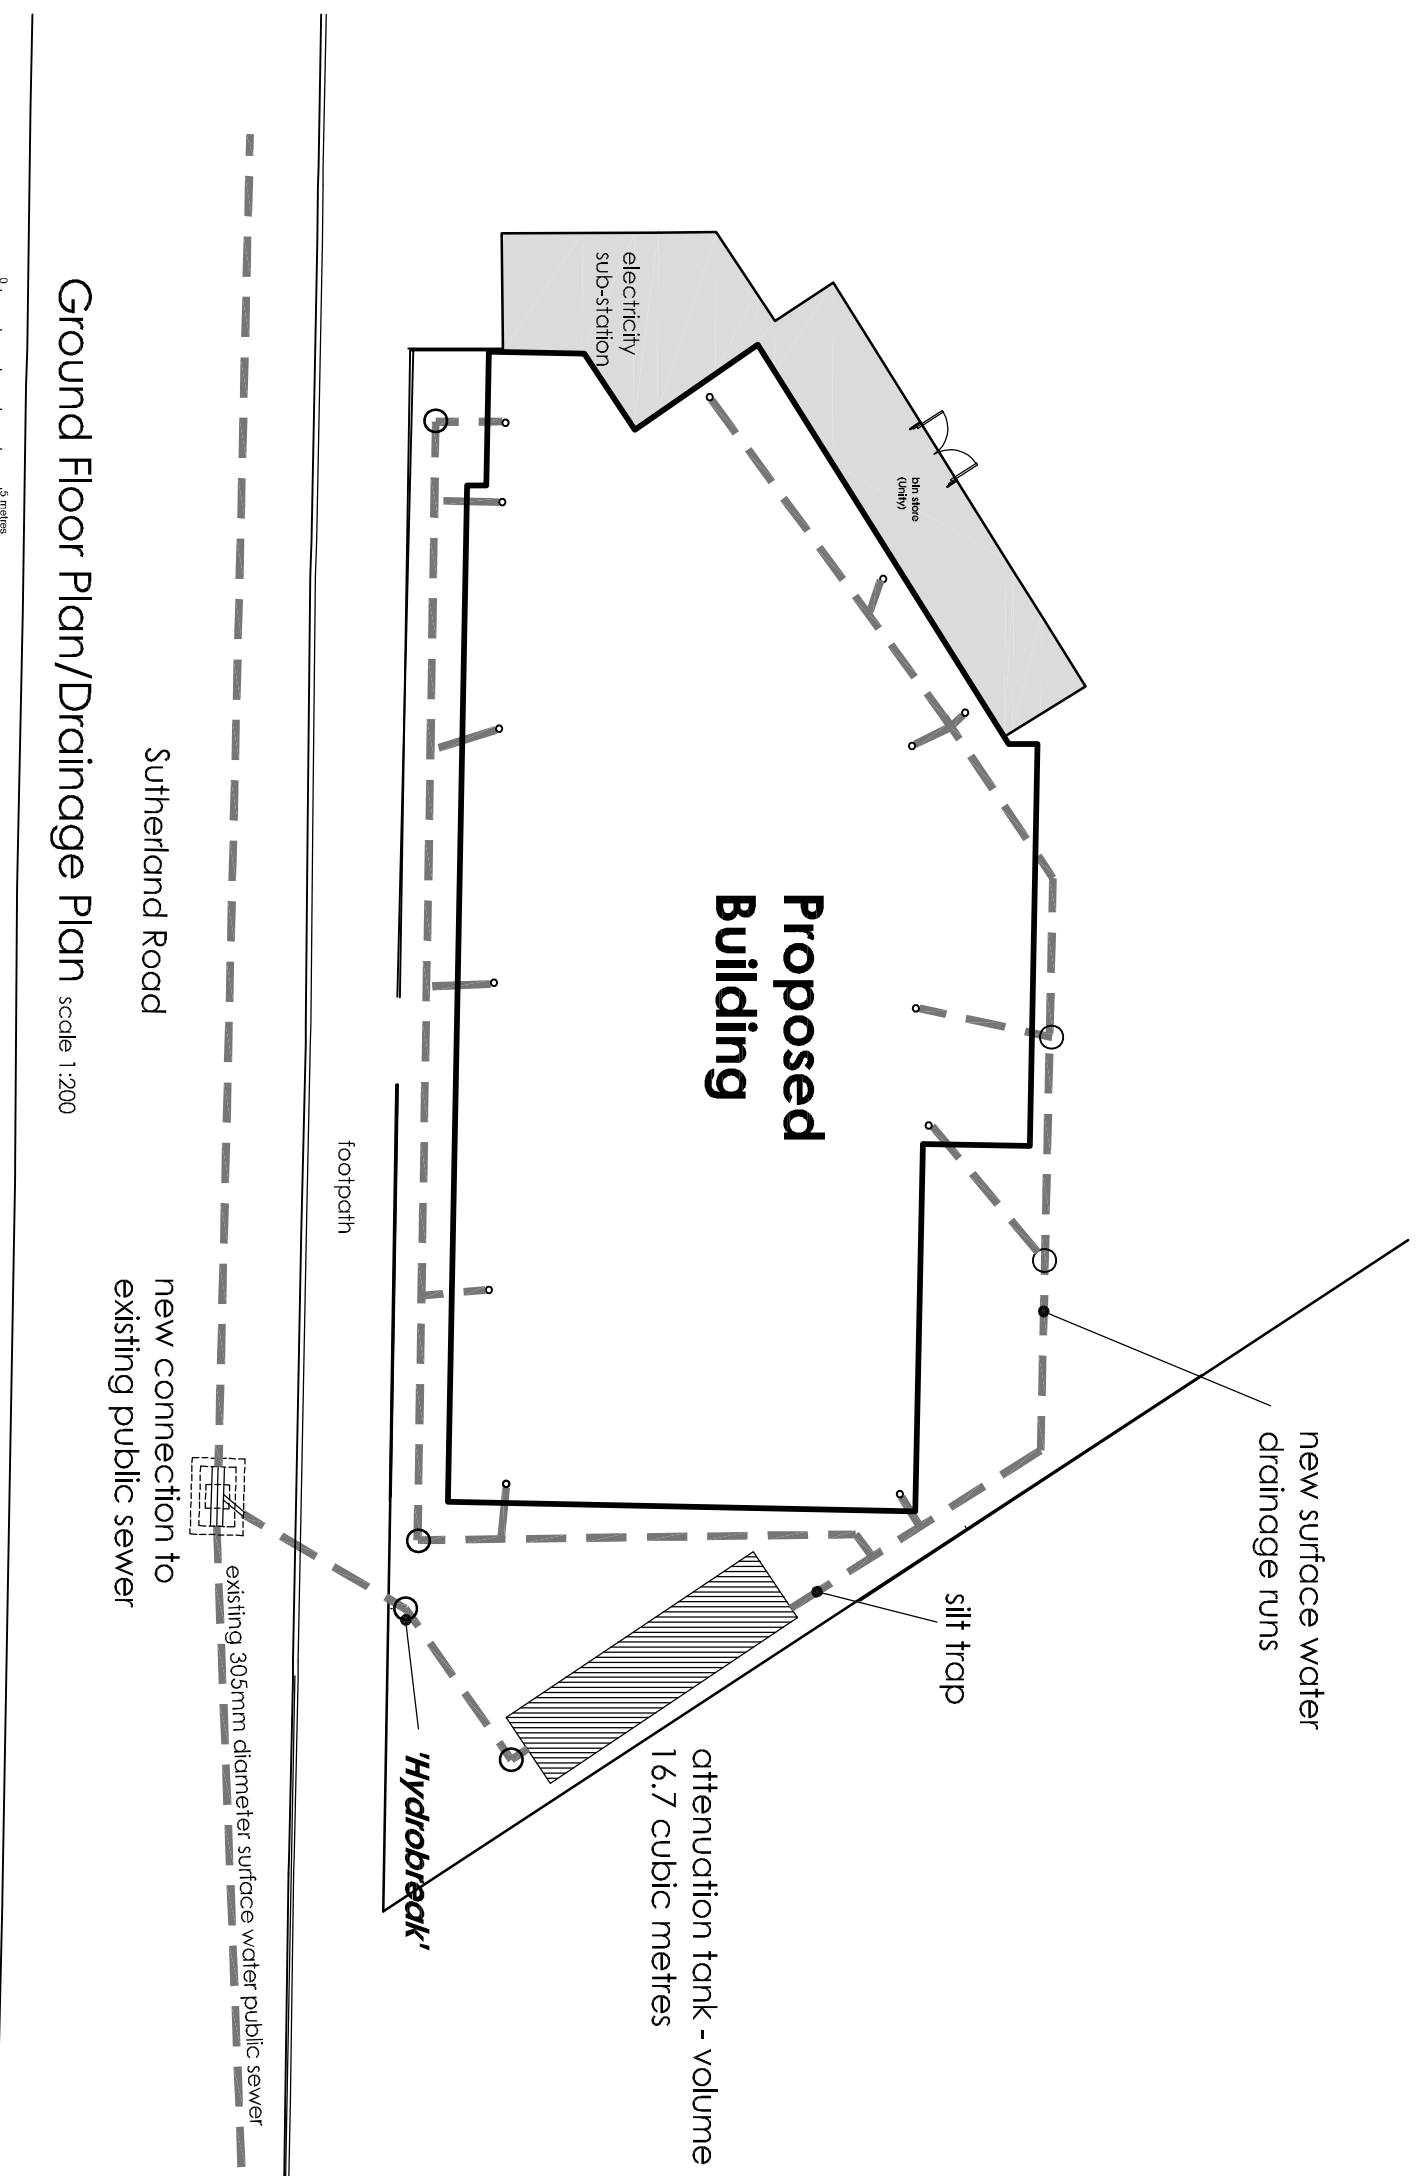

client

project
Proposed Residential Development
22 Sutherland Road,
Walthamstow, London, E17 6BH

title
Drainage Layout Surface Water

drawing number
3447:32

scale
1:200 A3

drawn by
MVDR

date
Nov 23

status
Planning

fisk
& associates
architects

20 chorley road, swinton, manchester, m27 5oj
t - 0161 793 5300 e - info@ralfisk.co.uk

