



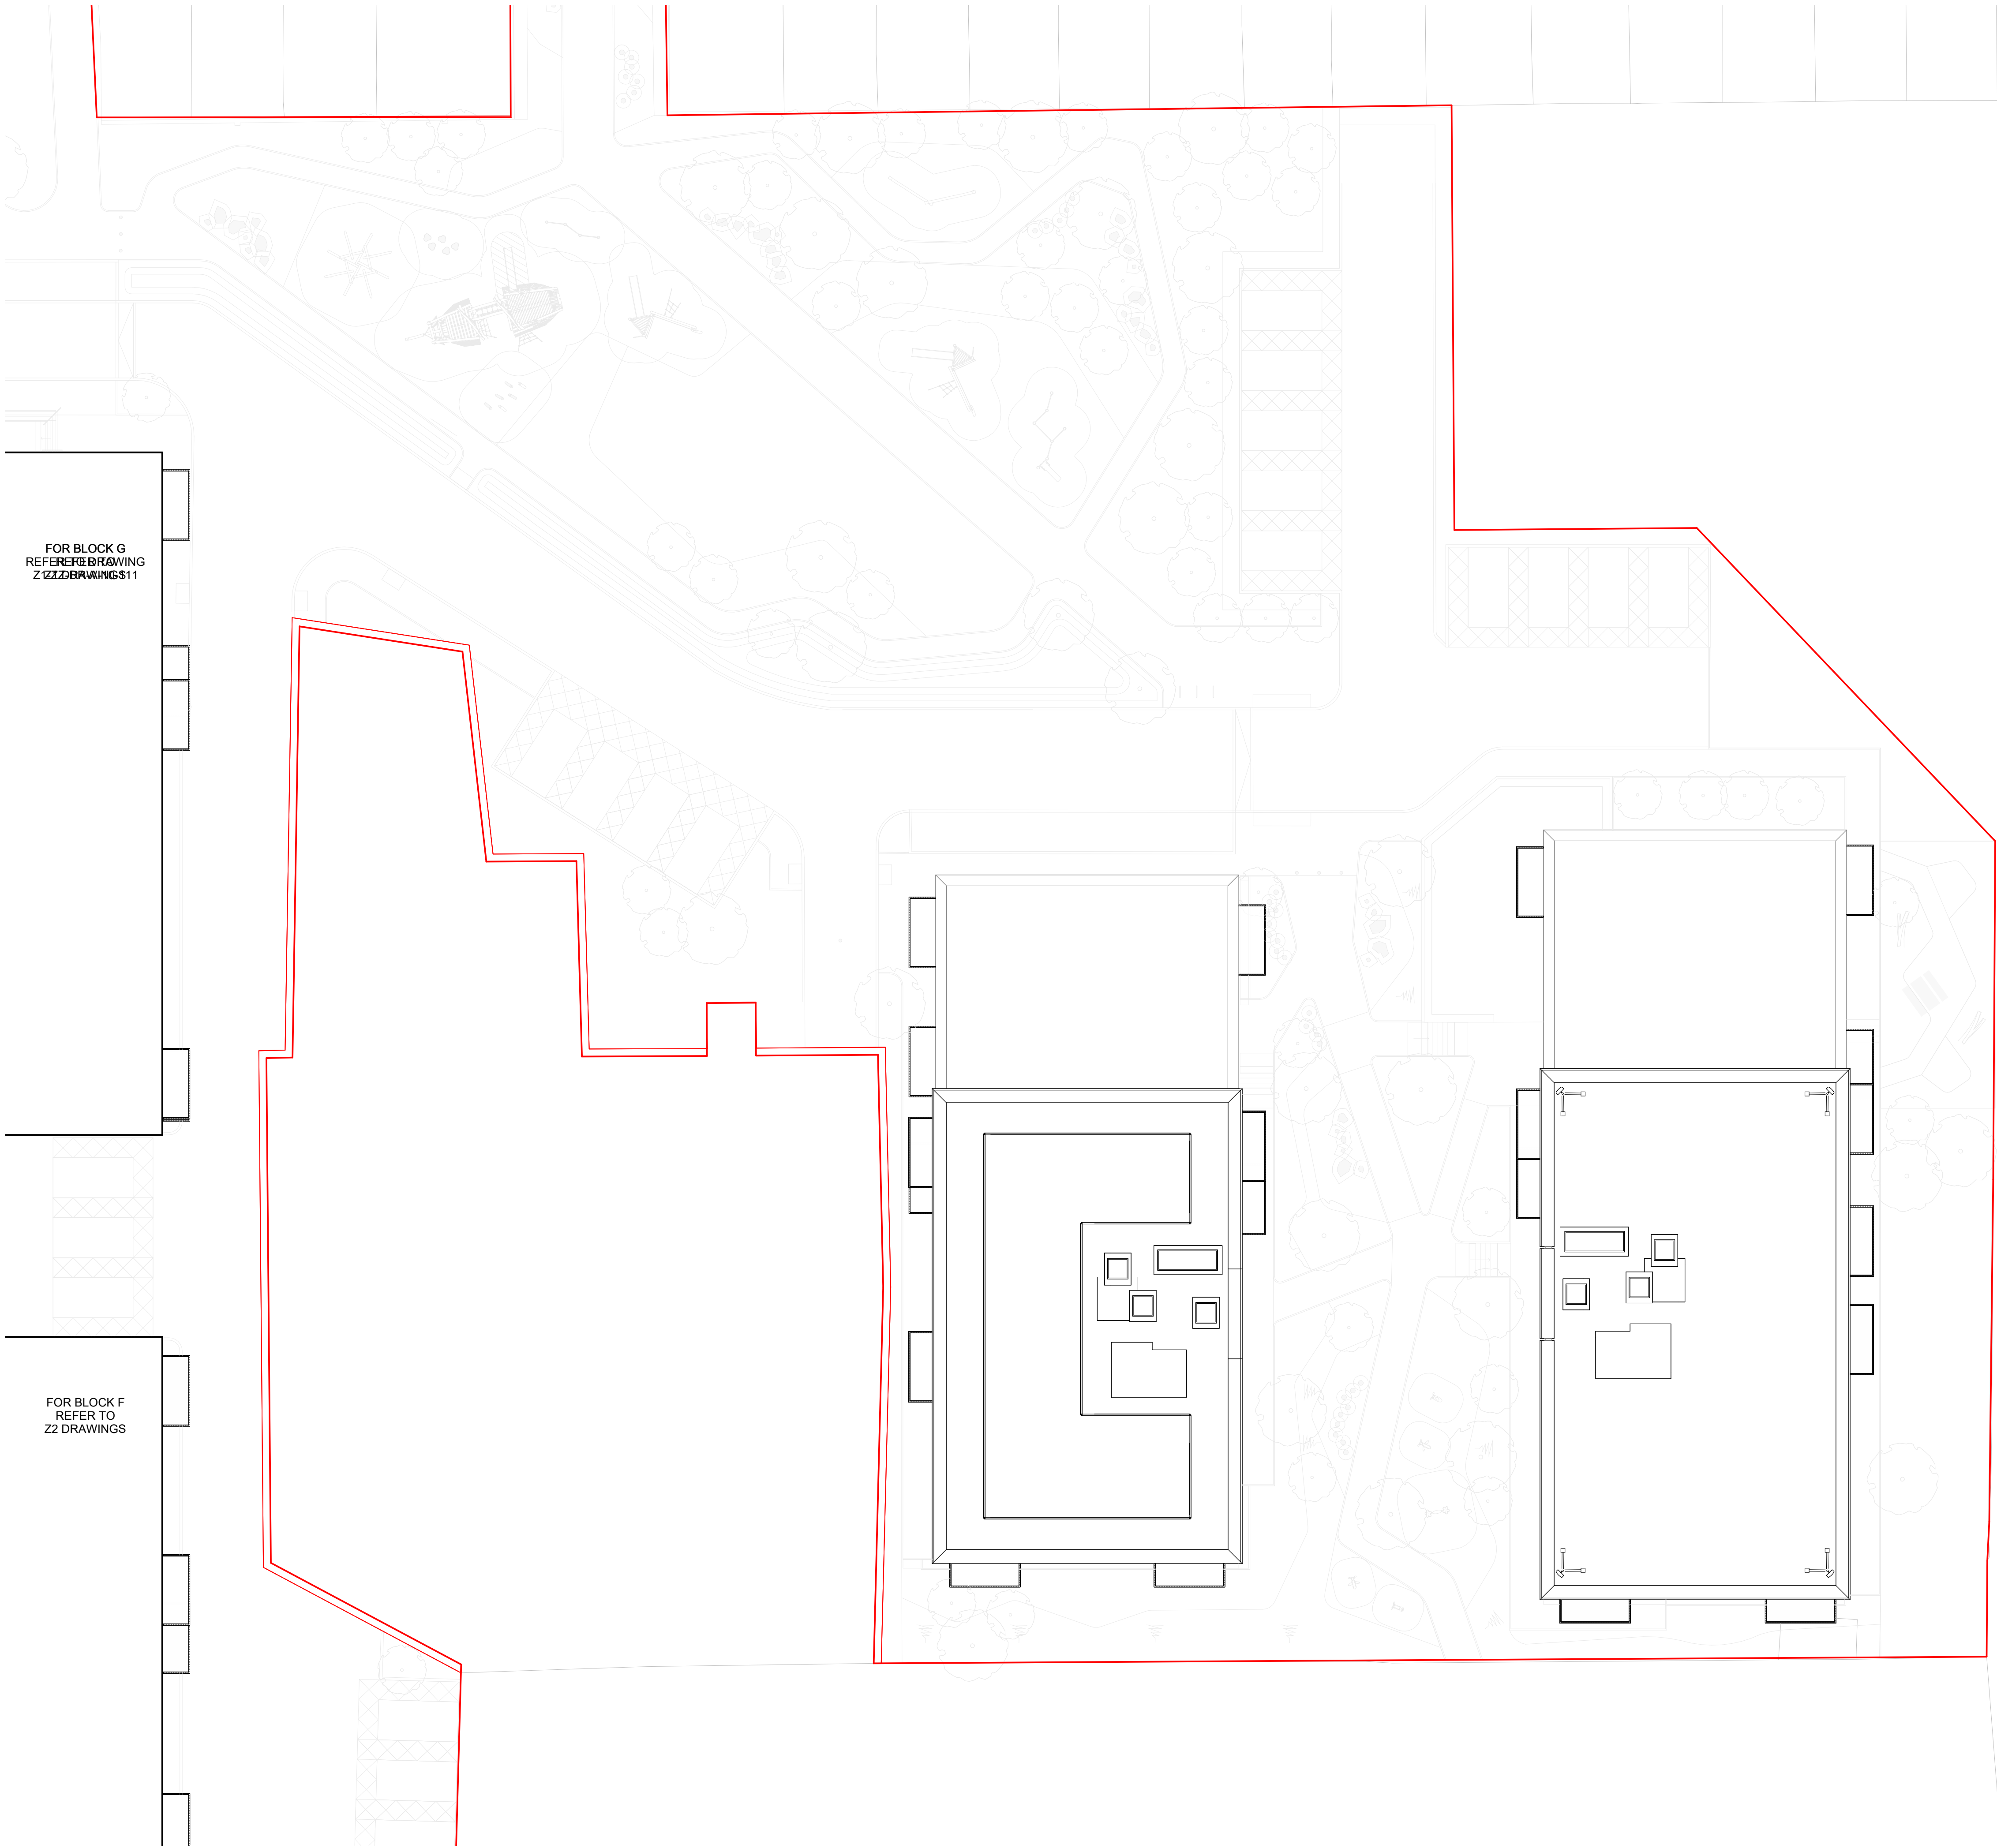

GENERAL NOTES:
This drawing is © 2025 PTE architects.
Use figured dimensions only.
All dimensions are in millimetres unless noted otherwise.
This drawing must be read in conjunction with all other relevant drawings and specifications from the Architect and other consultants.
If in doubt, ask.

SETTING OUT NOTES:
All setting out to be confirmed on site prior to construction - any discrepancy must be immediately reported to the Architect.
All setting out to face of structure or to grid.
All partitions set out to studwork or structure.
For setting out and specification of M&E services refer to M&E Consultants documents.
For setting out and specification of structure refer to Structural Engineer's documents.

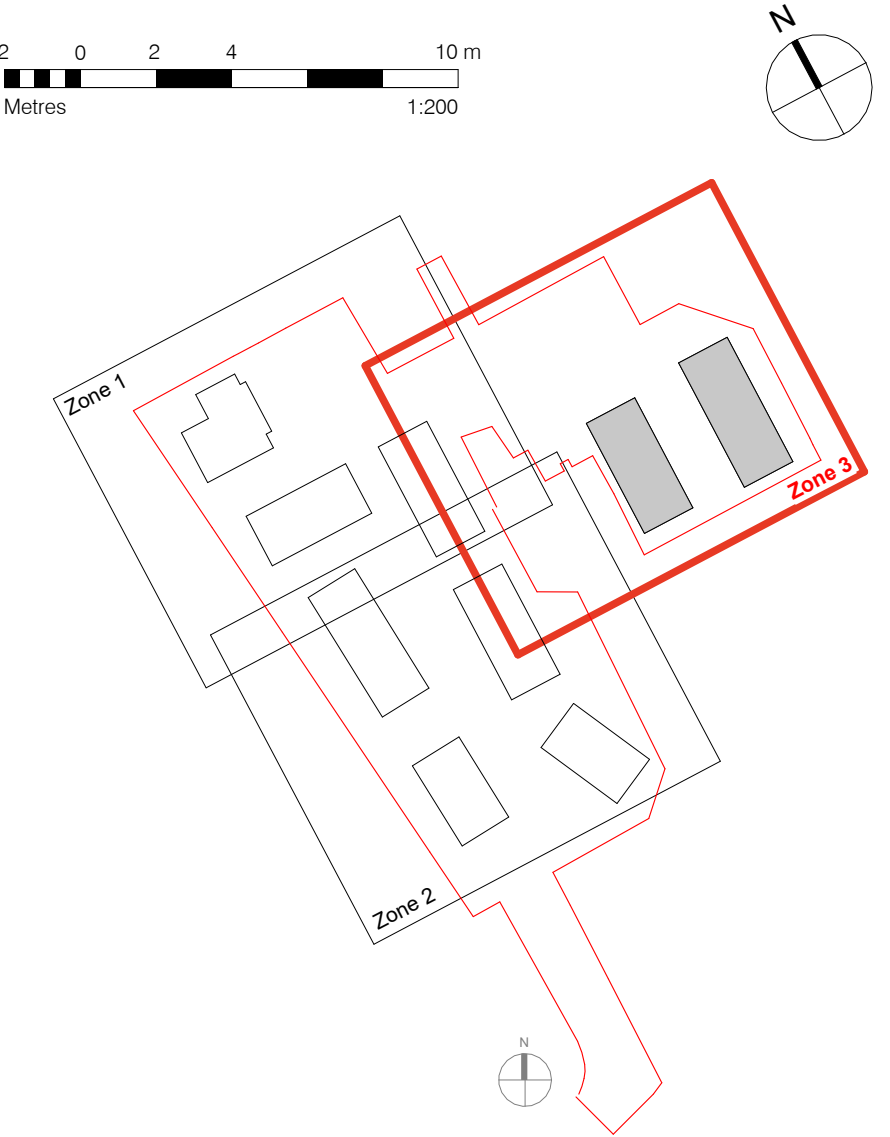

rev.	date	description	drawn	checked
P1	26.09.25	First Issue	TR	NB

A3 - PLANNING

Diespeker Wharf
38 Graham Street
London N1 8JX
020 7336 7777
forename.surname@ptea.co.uk
@ptearchitects
www.pollardthomasedwards.co.uk

**Pollard
Thomas
Edwards**

project	job number	drawn	scale	date created
Lea Bridge Gasworks	W406	TR	1 : 200@A1	Sep' 25
drawing title	drawing number	suitability	revision	
Zone 3 - Buildings I & J Roof Plan	W406- POL02- Z3-ZZ-DR-A-10-163	A3	P1	